


KEY	225C(5) CARRIER DRAIN INDICATING SIZE AND GROUP.	zzzzzzz LINEAR SOAKAWAY INDICATING LENGTH.	⊗ MANHOLE COVER LEVELS SHOWN PREFIXED C.L. ALL OTHER LEVELS REFER TO PIPE INVERTS.	⊠ SOAKAWAY DIGIT SIGNIFIES TYPE. COVER LEVELS PREFIXED C.L. ALL OTHER LEVELS REFER TO PIPE INVERTS.
	150F FRENCH DRAIN INDICATING SIZE.	1800R RUBBLE DRAIN INDICATING DEPTH.	⊙ CATCHPIT COVER LEVELS SHOWN PREFIXED C.L. ALL OTHER LEVELS REFER TO PIPE INVERTS.	▣ OIL / SILT TRAP.
	150SF SEALED FRENCH DRAIN INDICATING SIZE.	->> c == INTERCEPTING DITCH WITH FLOW CONTROL BREAK.	RE1 RODDING EYE INDICATING TYPE. COVER LEVELS PREFIXED C.L. ALL OTHER LEVELS REFER TO PIPE INVERTS.	▣ HEADWALL TYPE AND SHAPE INDICATED (G.L. APPROX)
				G1 GULLY INDICATING TYPE

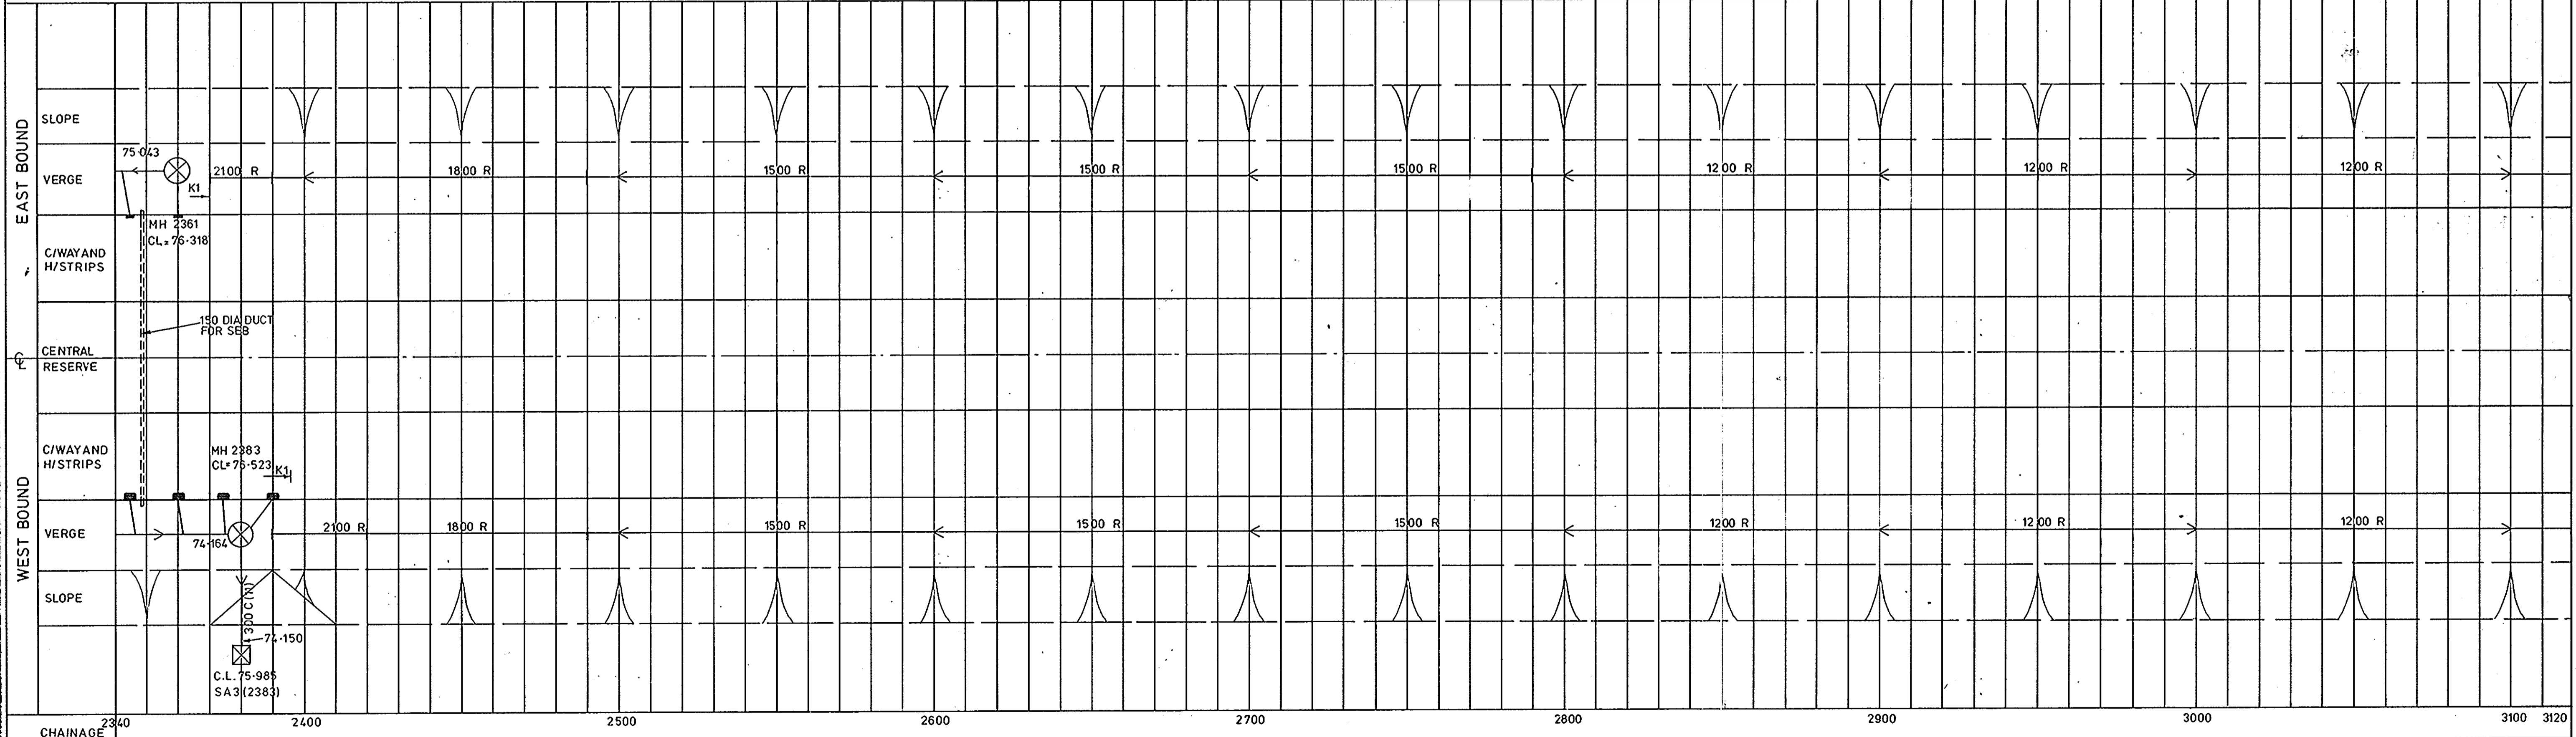

DEPARTMENT OF TRANSPORT  
 SOUTH EAST REGIONAL OFFICE  
 DIRECTOR (TRANSPORT)  
 FEDERATED HOUSE,  
 LONDON ROAD,  
 DORKING, SURREY. RH4 1SZ

A 303  
 ANDOVER - THRUXTON  
 DRAINAGE LAYOUT DIAGRAM - CH.1560 TO CH.3120

<b>AS BUILT</b>		
NO	REVISIONS	DATE

SCALE	NTS
DRAWN	PJ
TRACED	JRC
CHECKED	JBC
APPROVED	RWS

<b>MOTT, HAY &amp; ANDERSON</b> CONSULTING ENGINEERS WINCHESTER HAMPSHIRE		
DATE	M.H.A. DRG. NO	REV.
FEB 88	268/R/3102	AB